



SCALE:
DRAWING No.




HOUSE PLAN

9.6mx9.9m

2 BEDROOMS


1 BATHROOM

SCALE:
DRAWING No.

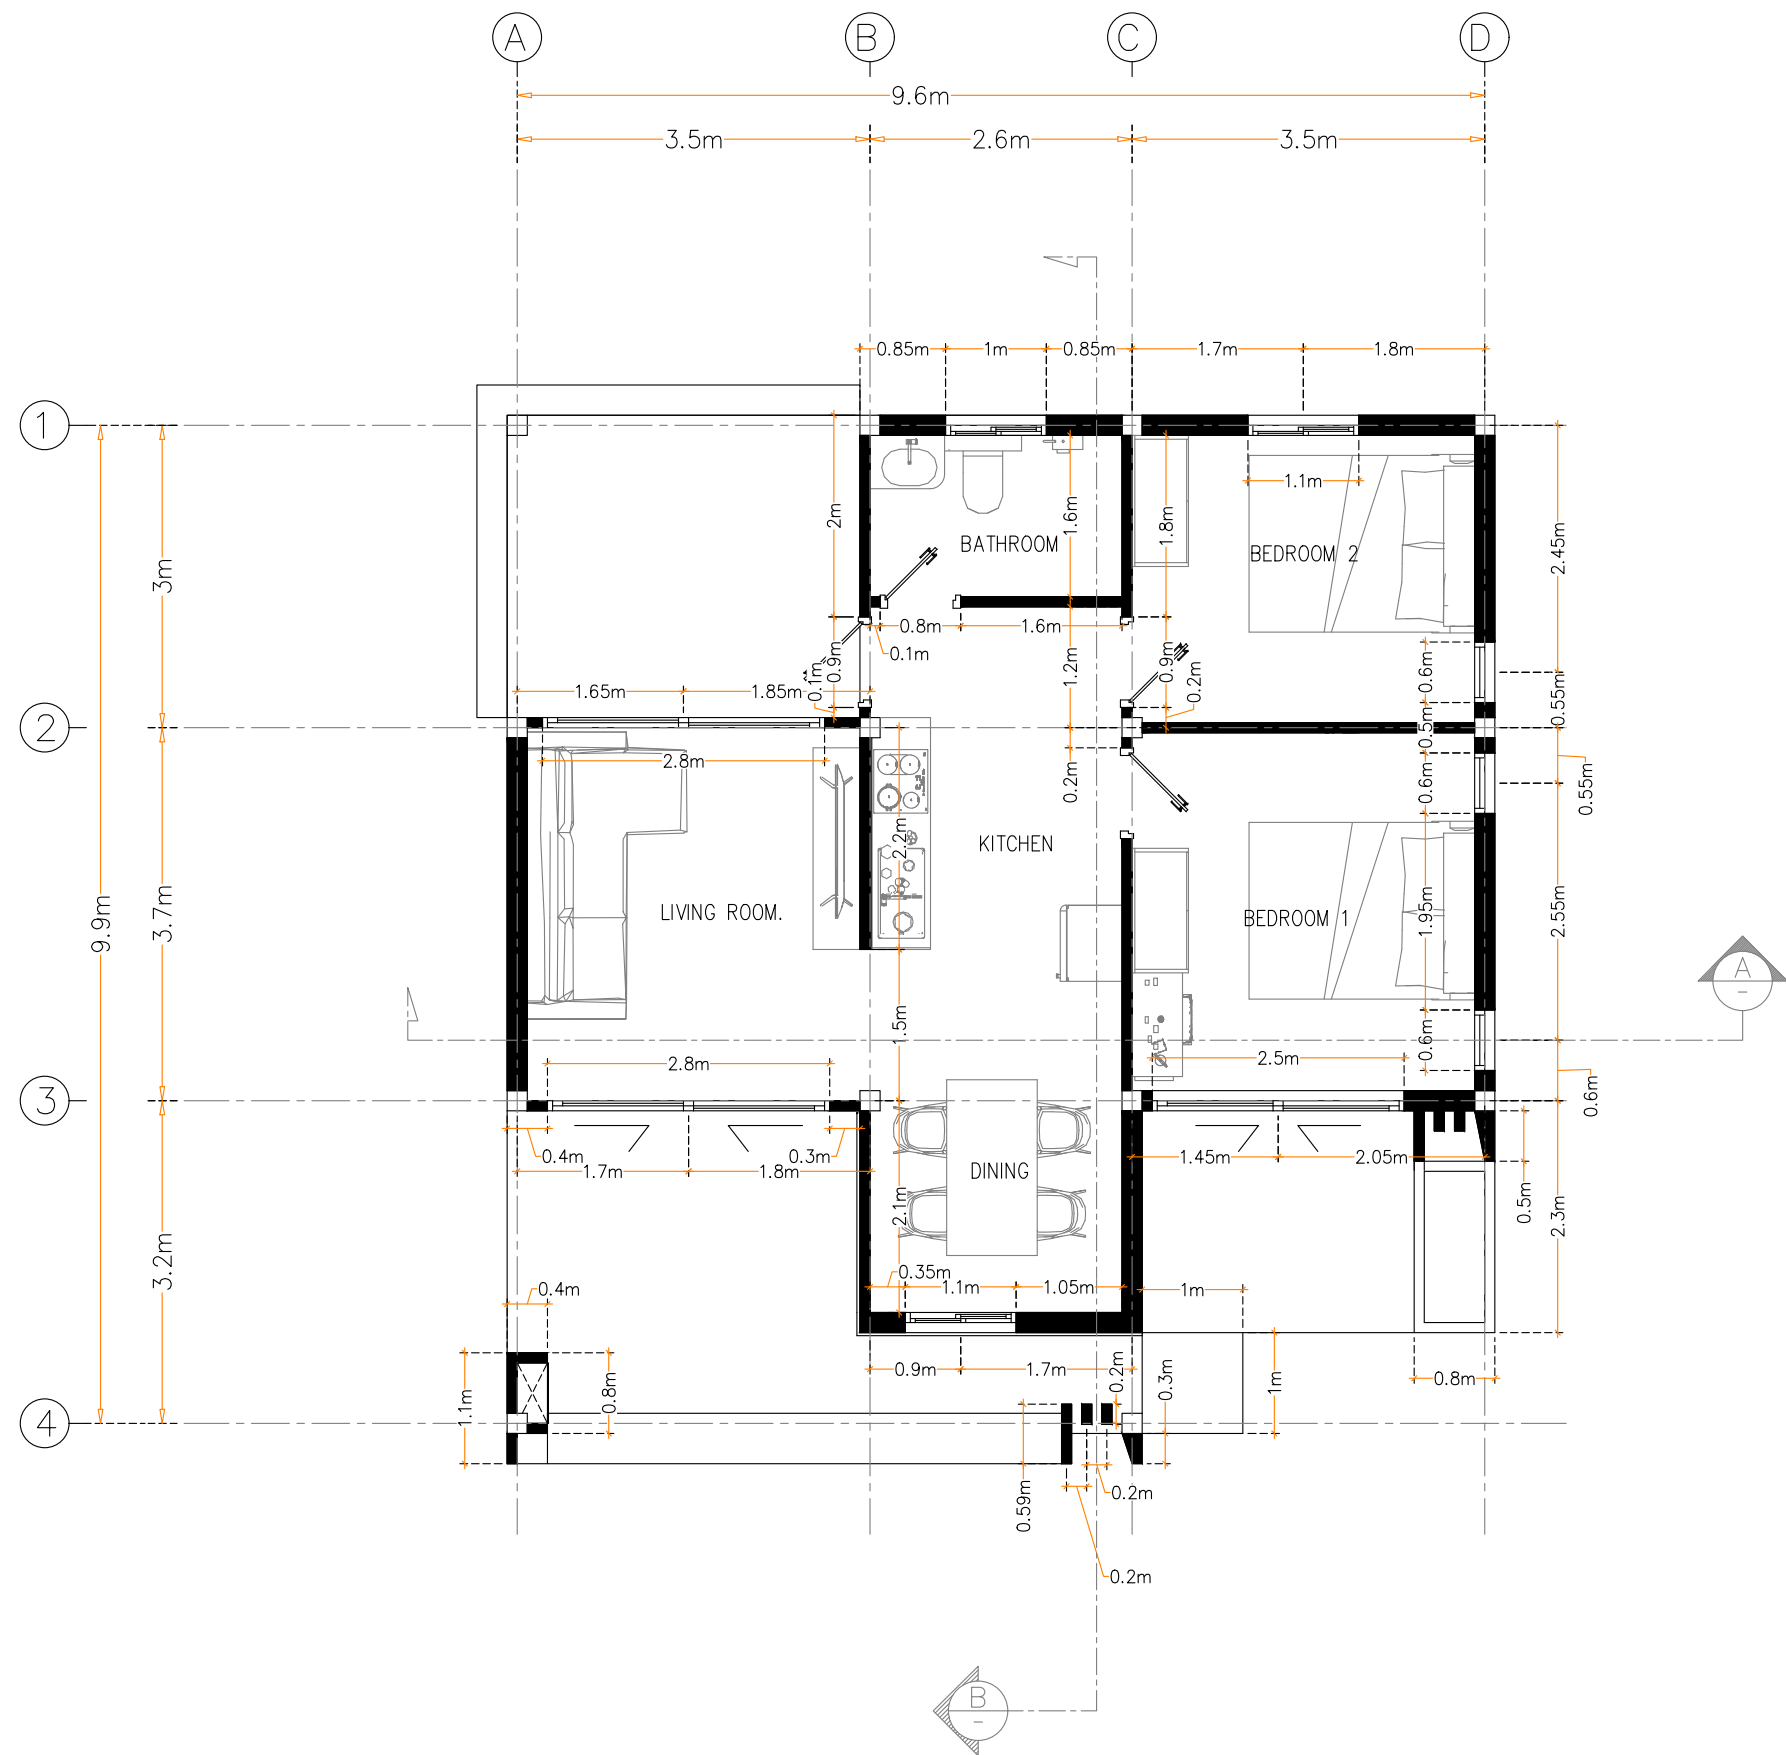


LAYOUT FLOOR PLAN
SCALE 1: 75 [A3]

SCALE:
DRAWING No.
A - 01

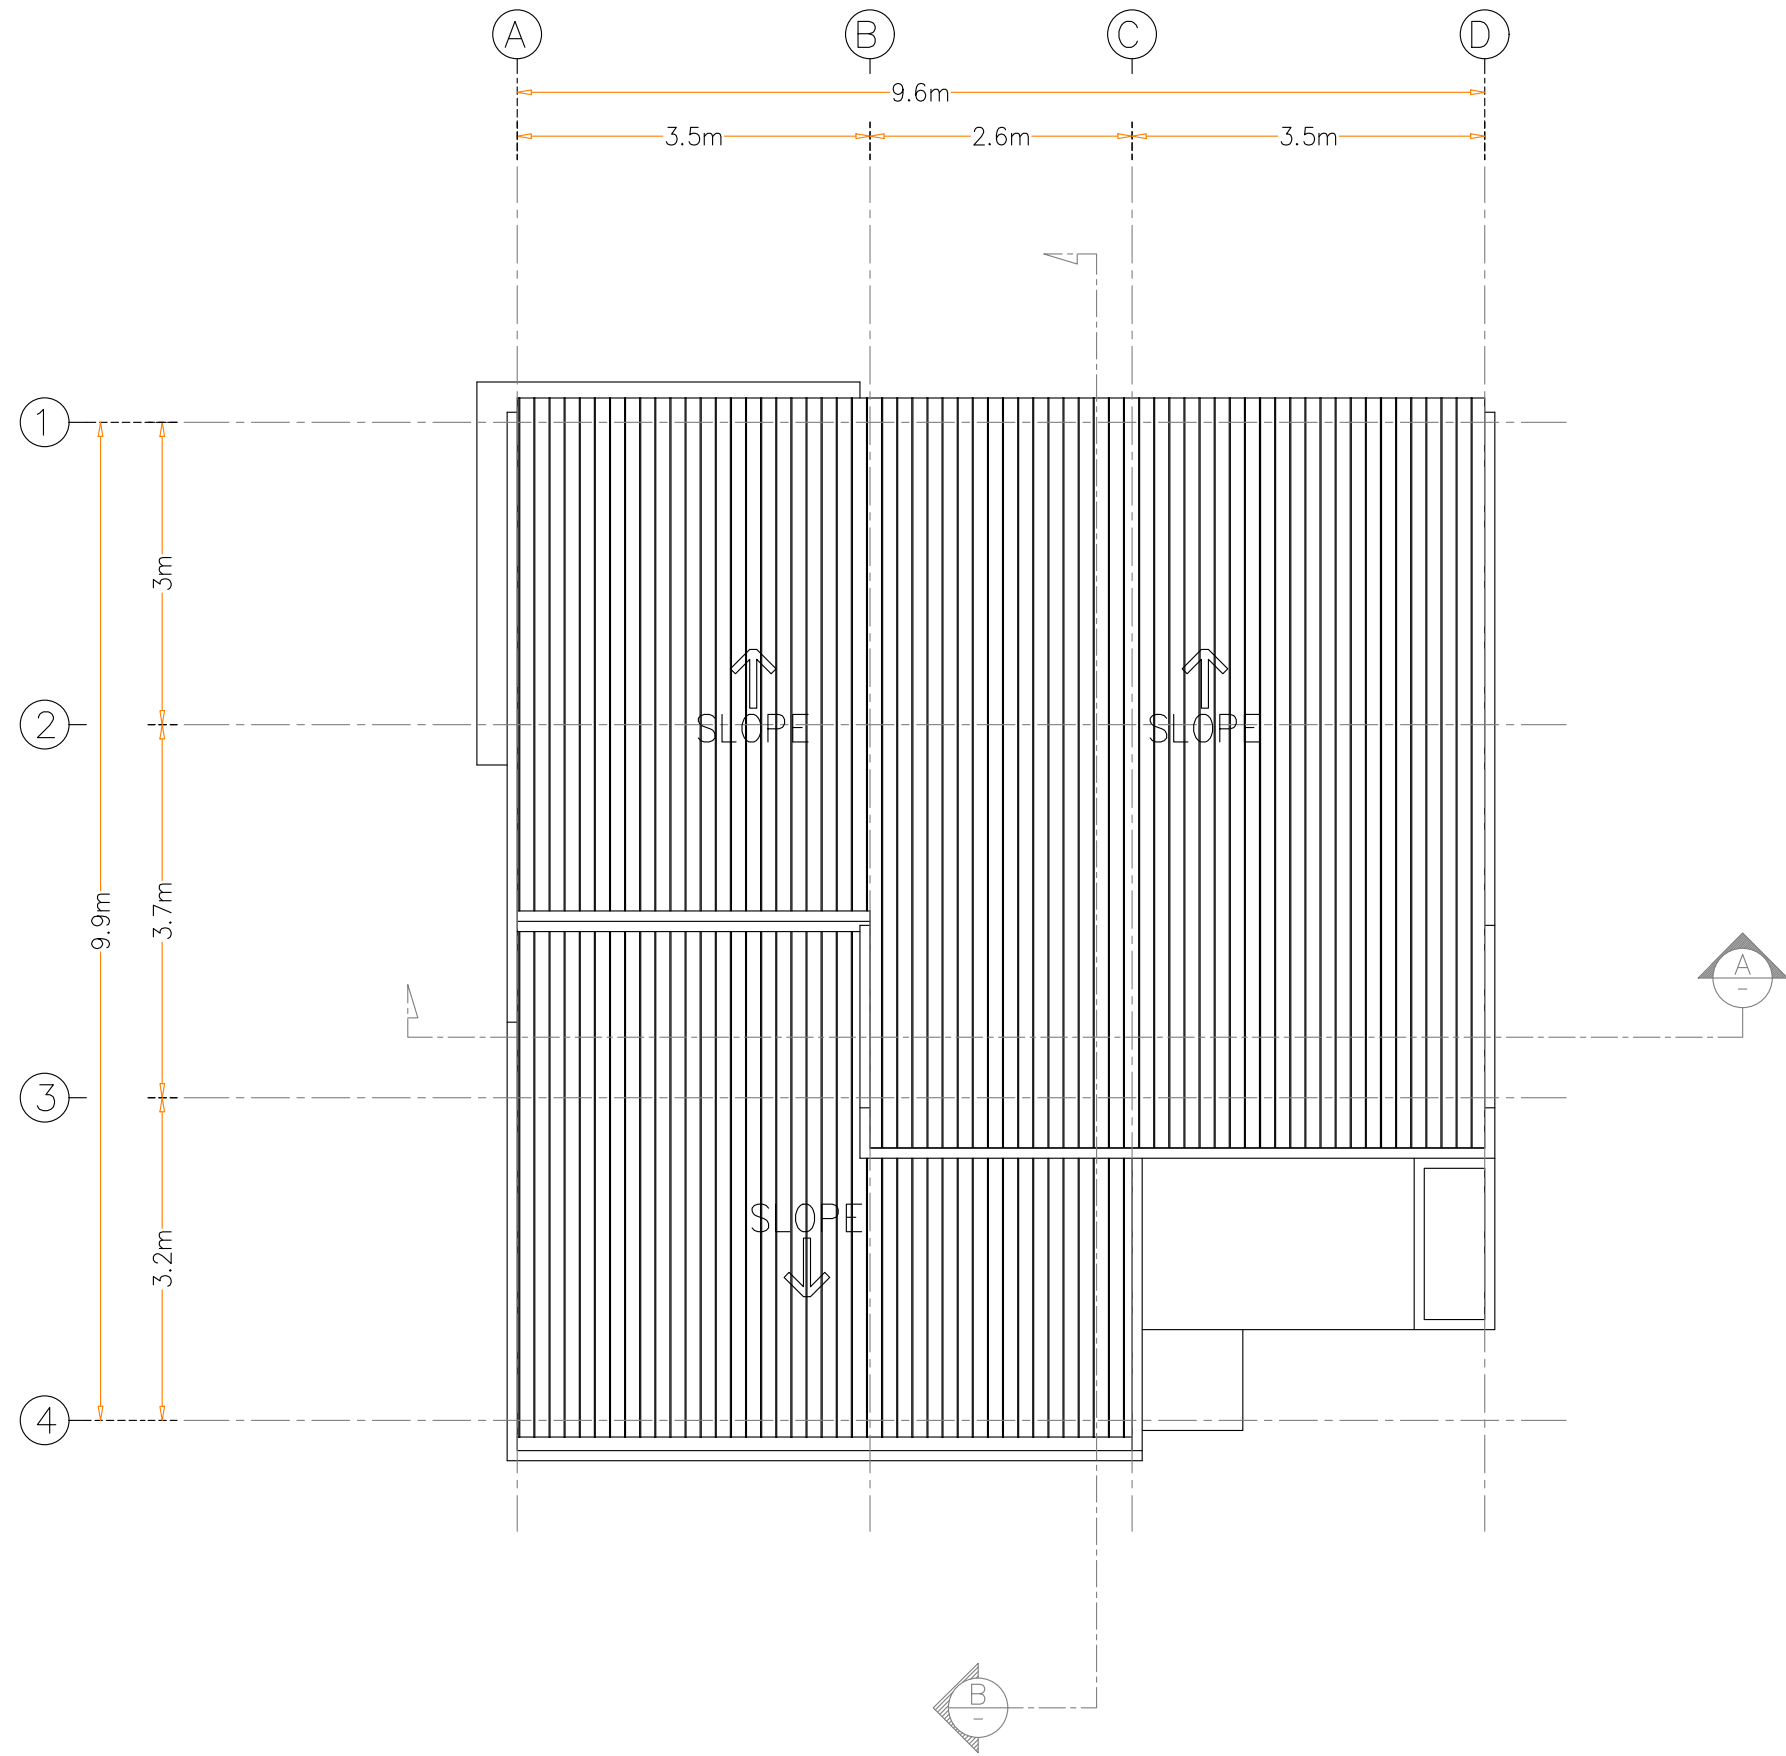

ROOF FLOOR PLAN
SCALE 1: 75 [A3]

SCALE:
DRAWING No.
A - 02

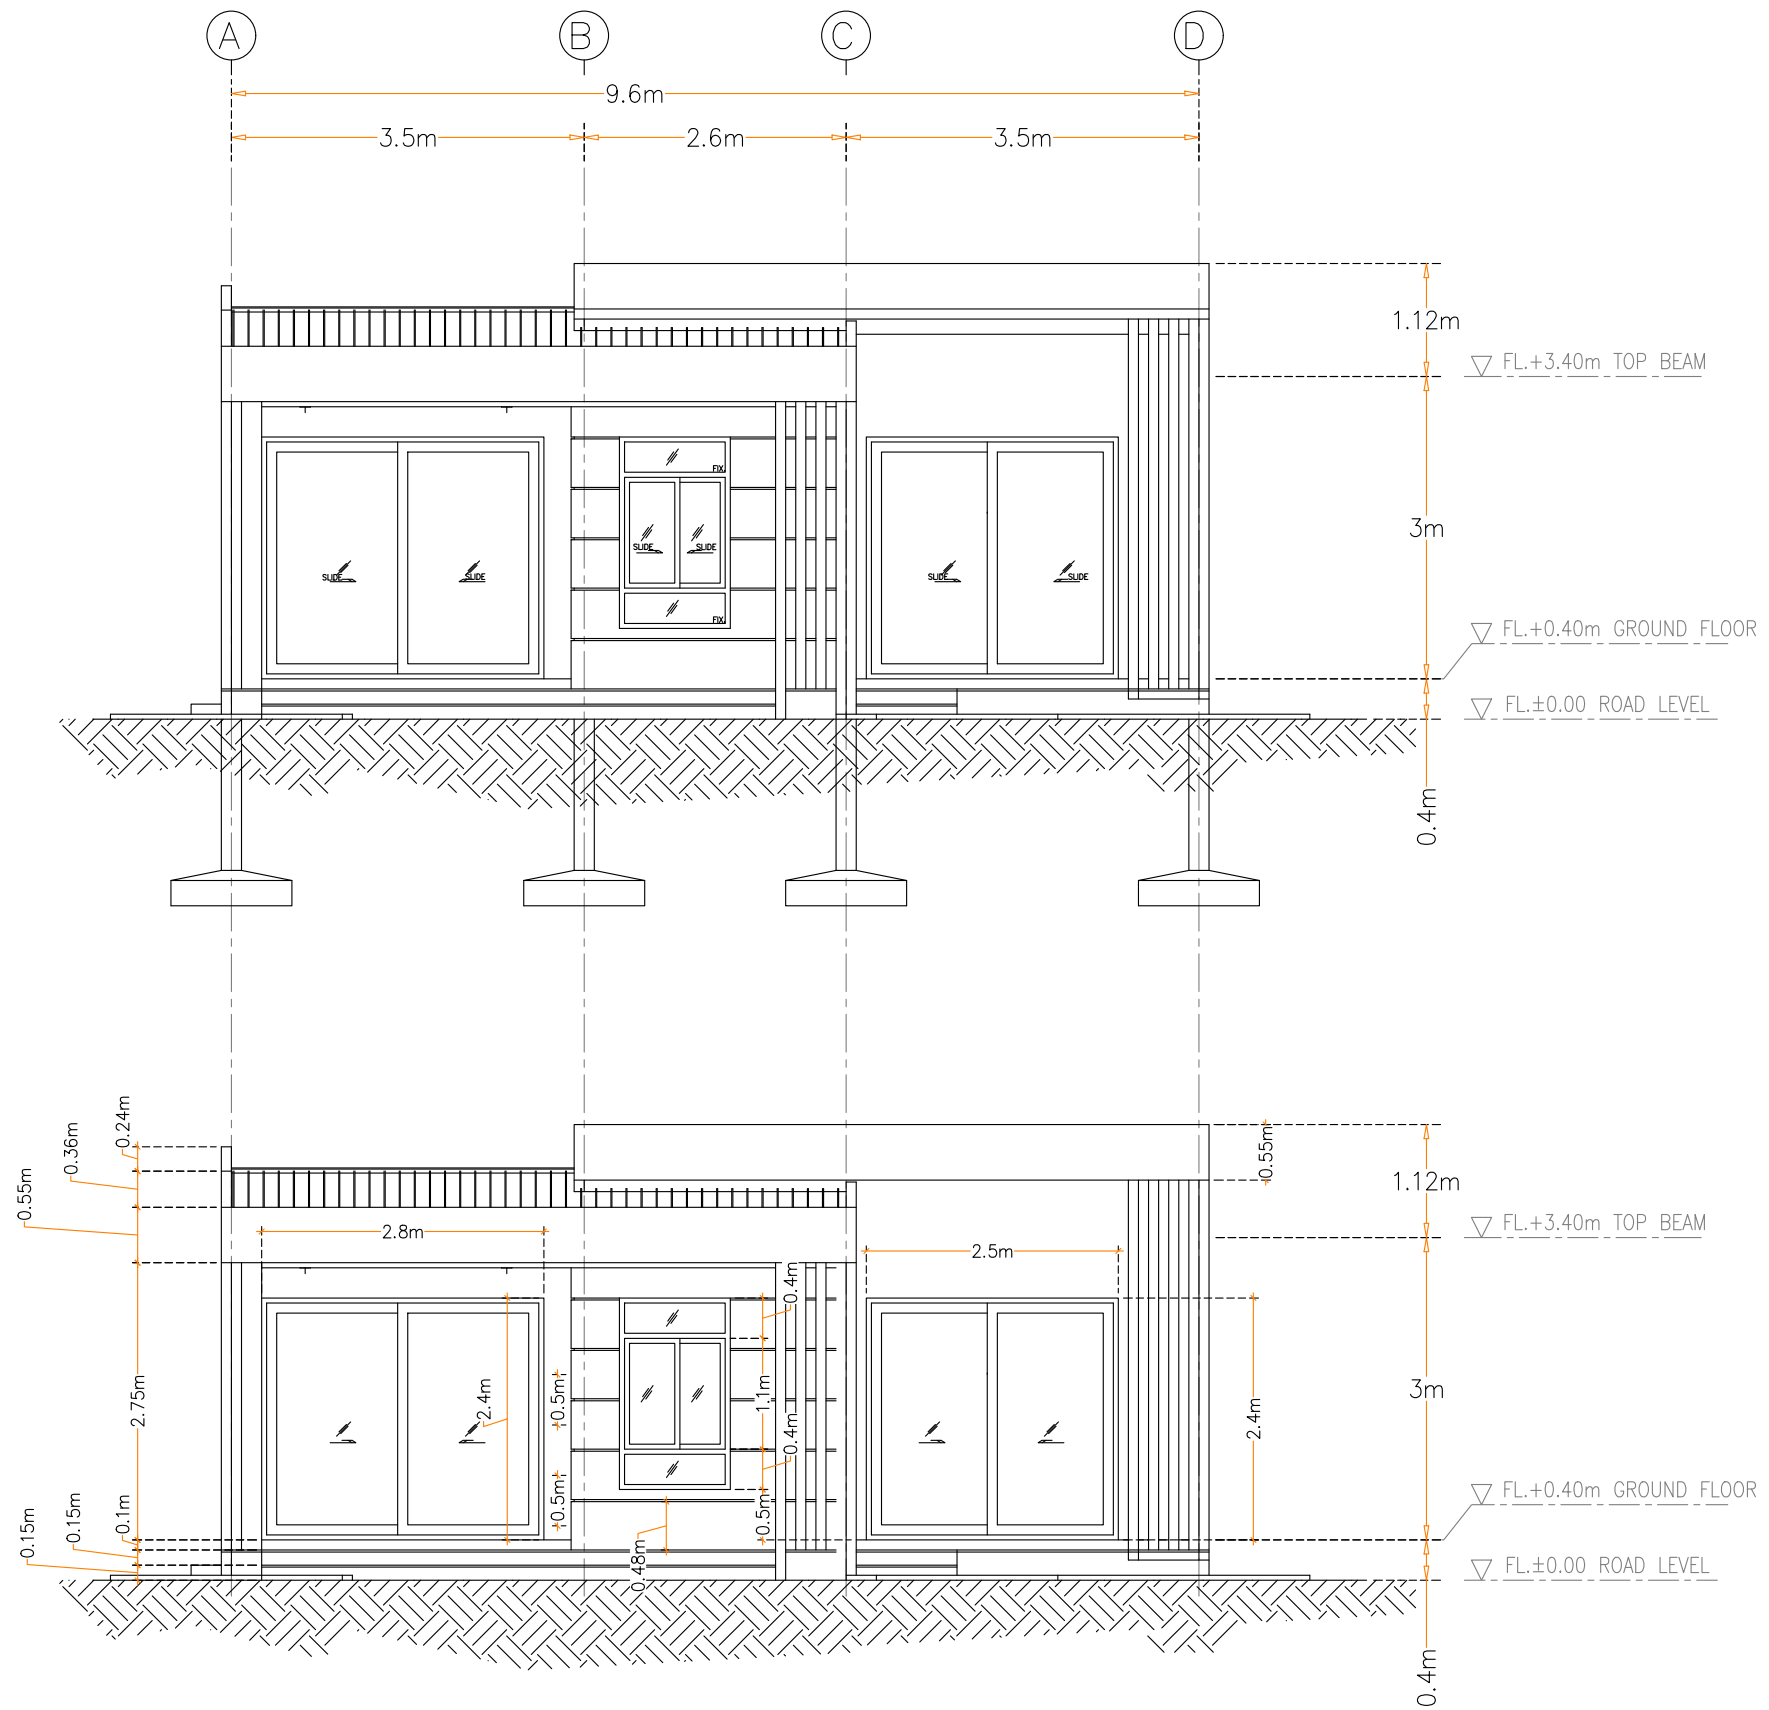

FRONT VIEW


SCALE

1: 75 [A3]

SCALE:

DRAWING No.

A - 03

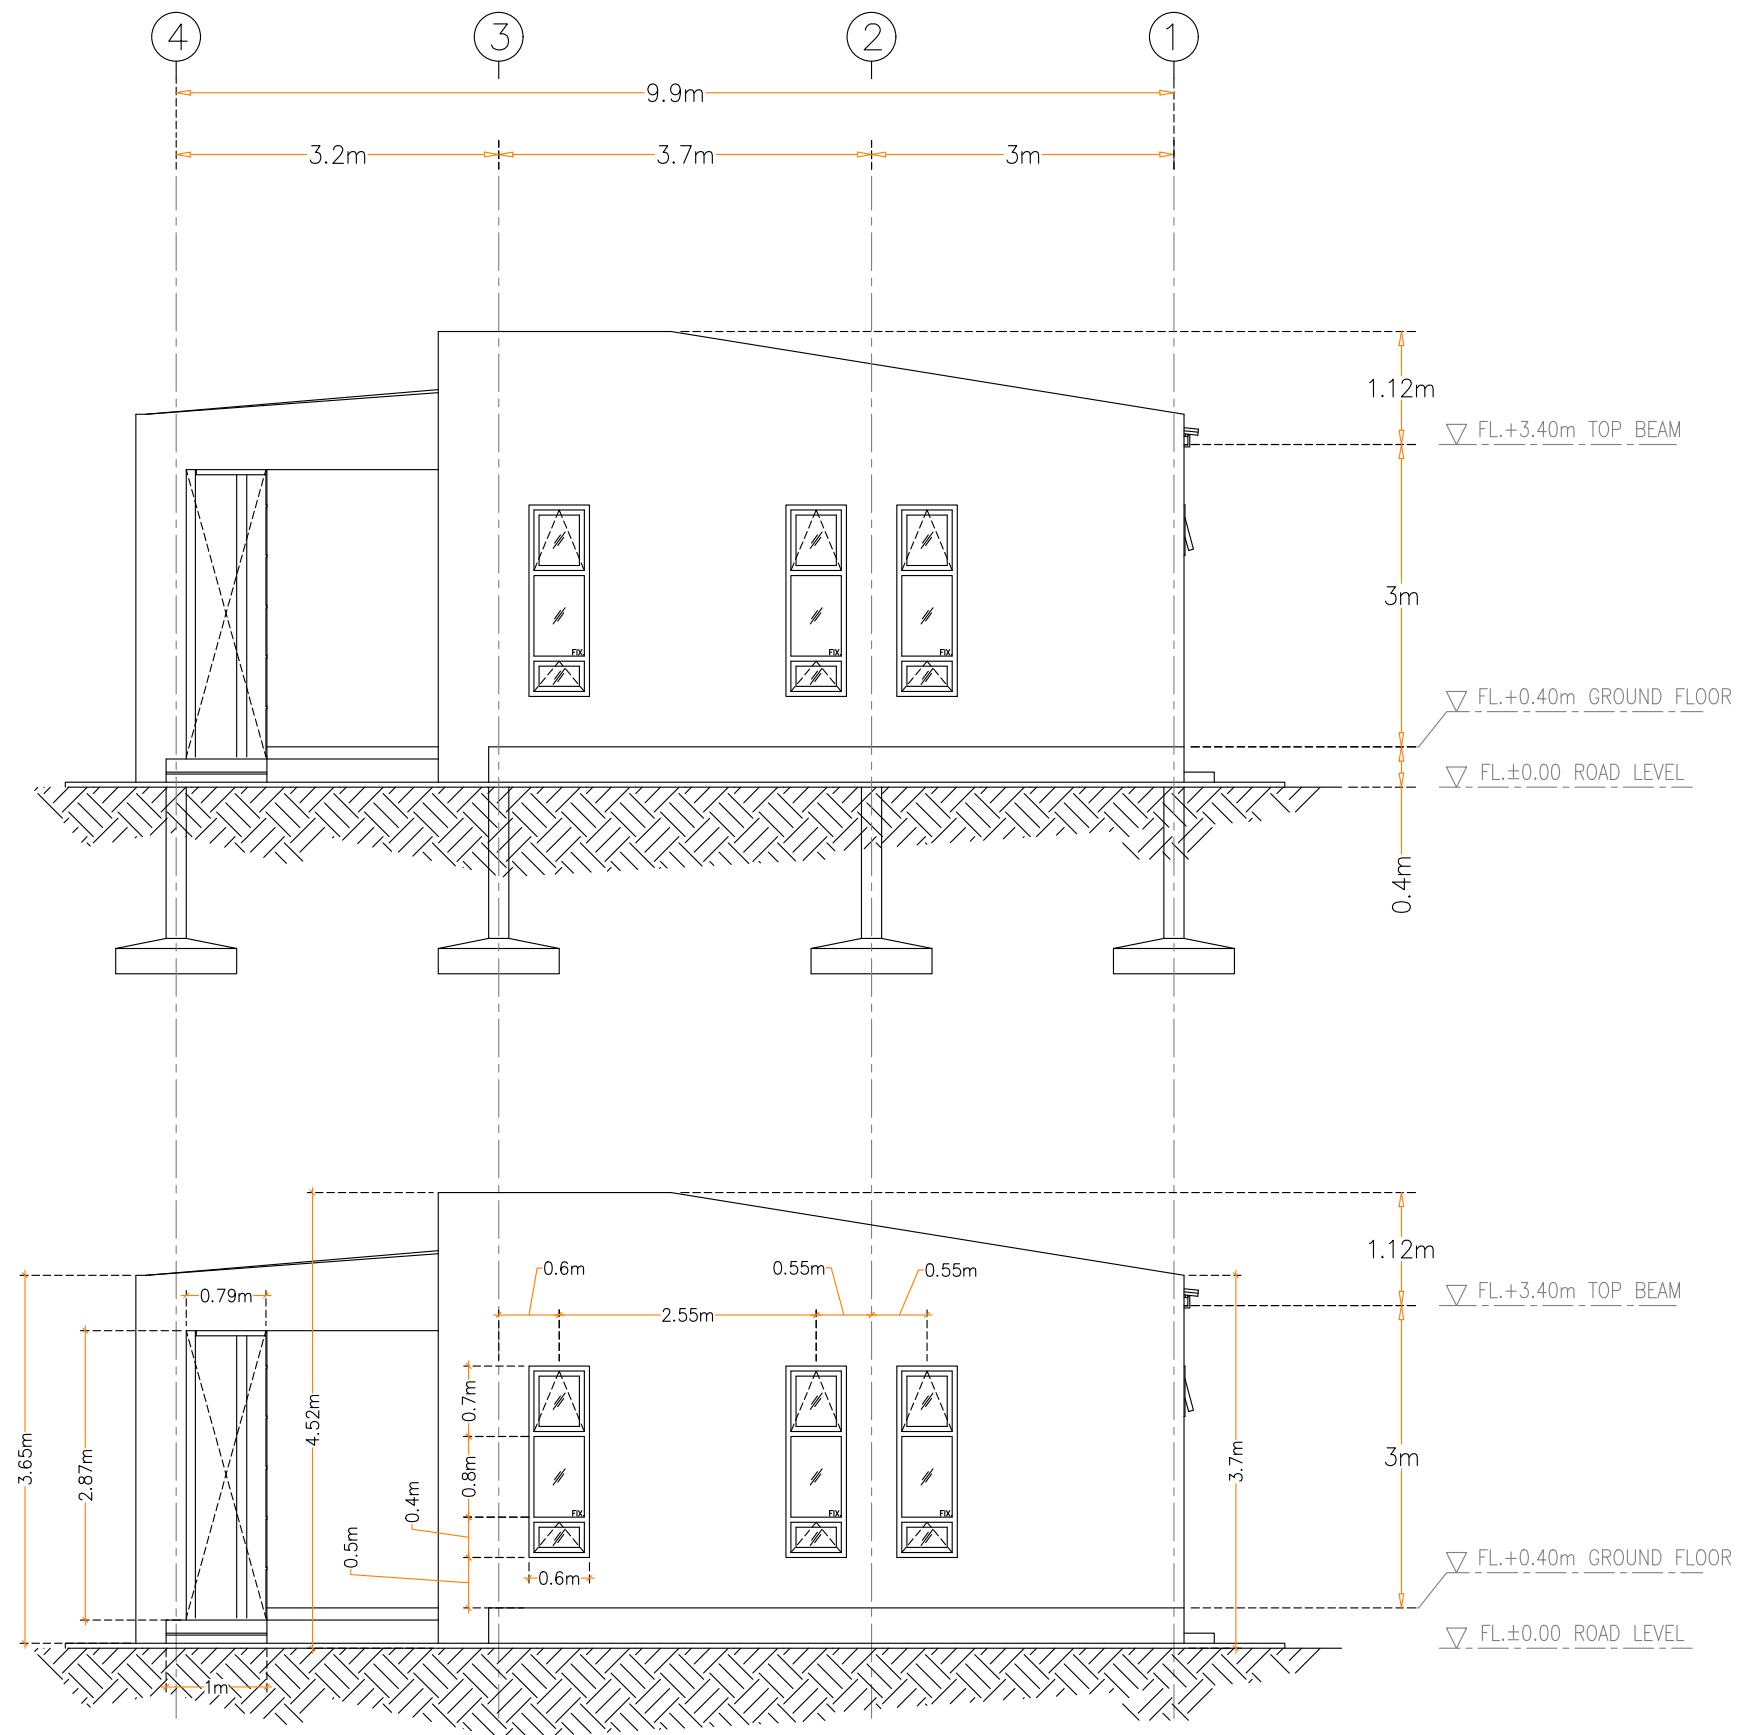

RIGHT VIEW


SCALE

1: 75 [A3]

SCALE:


DRAWING No.

A - 04

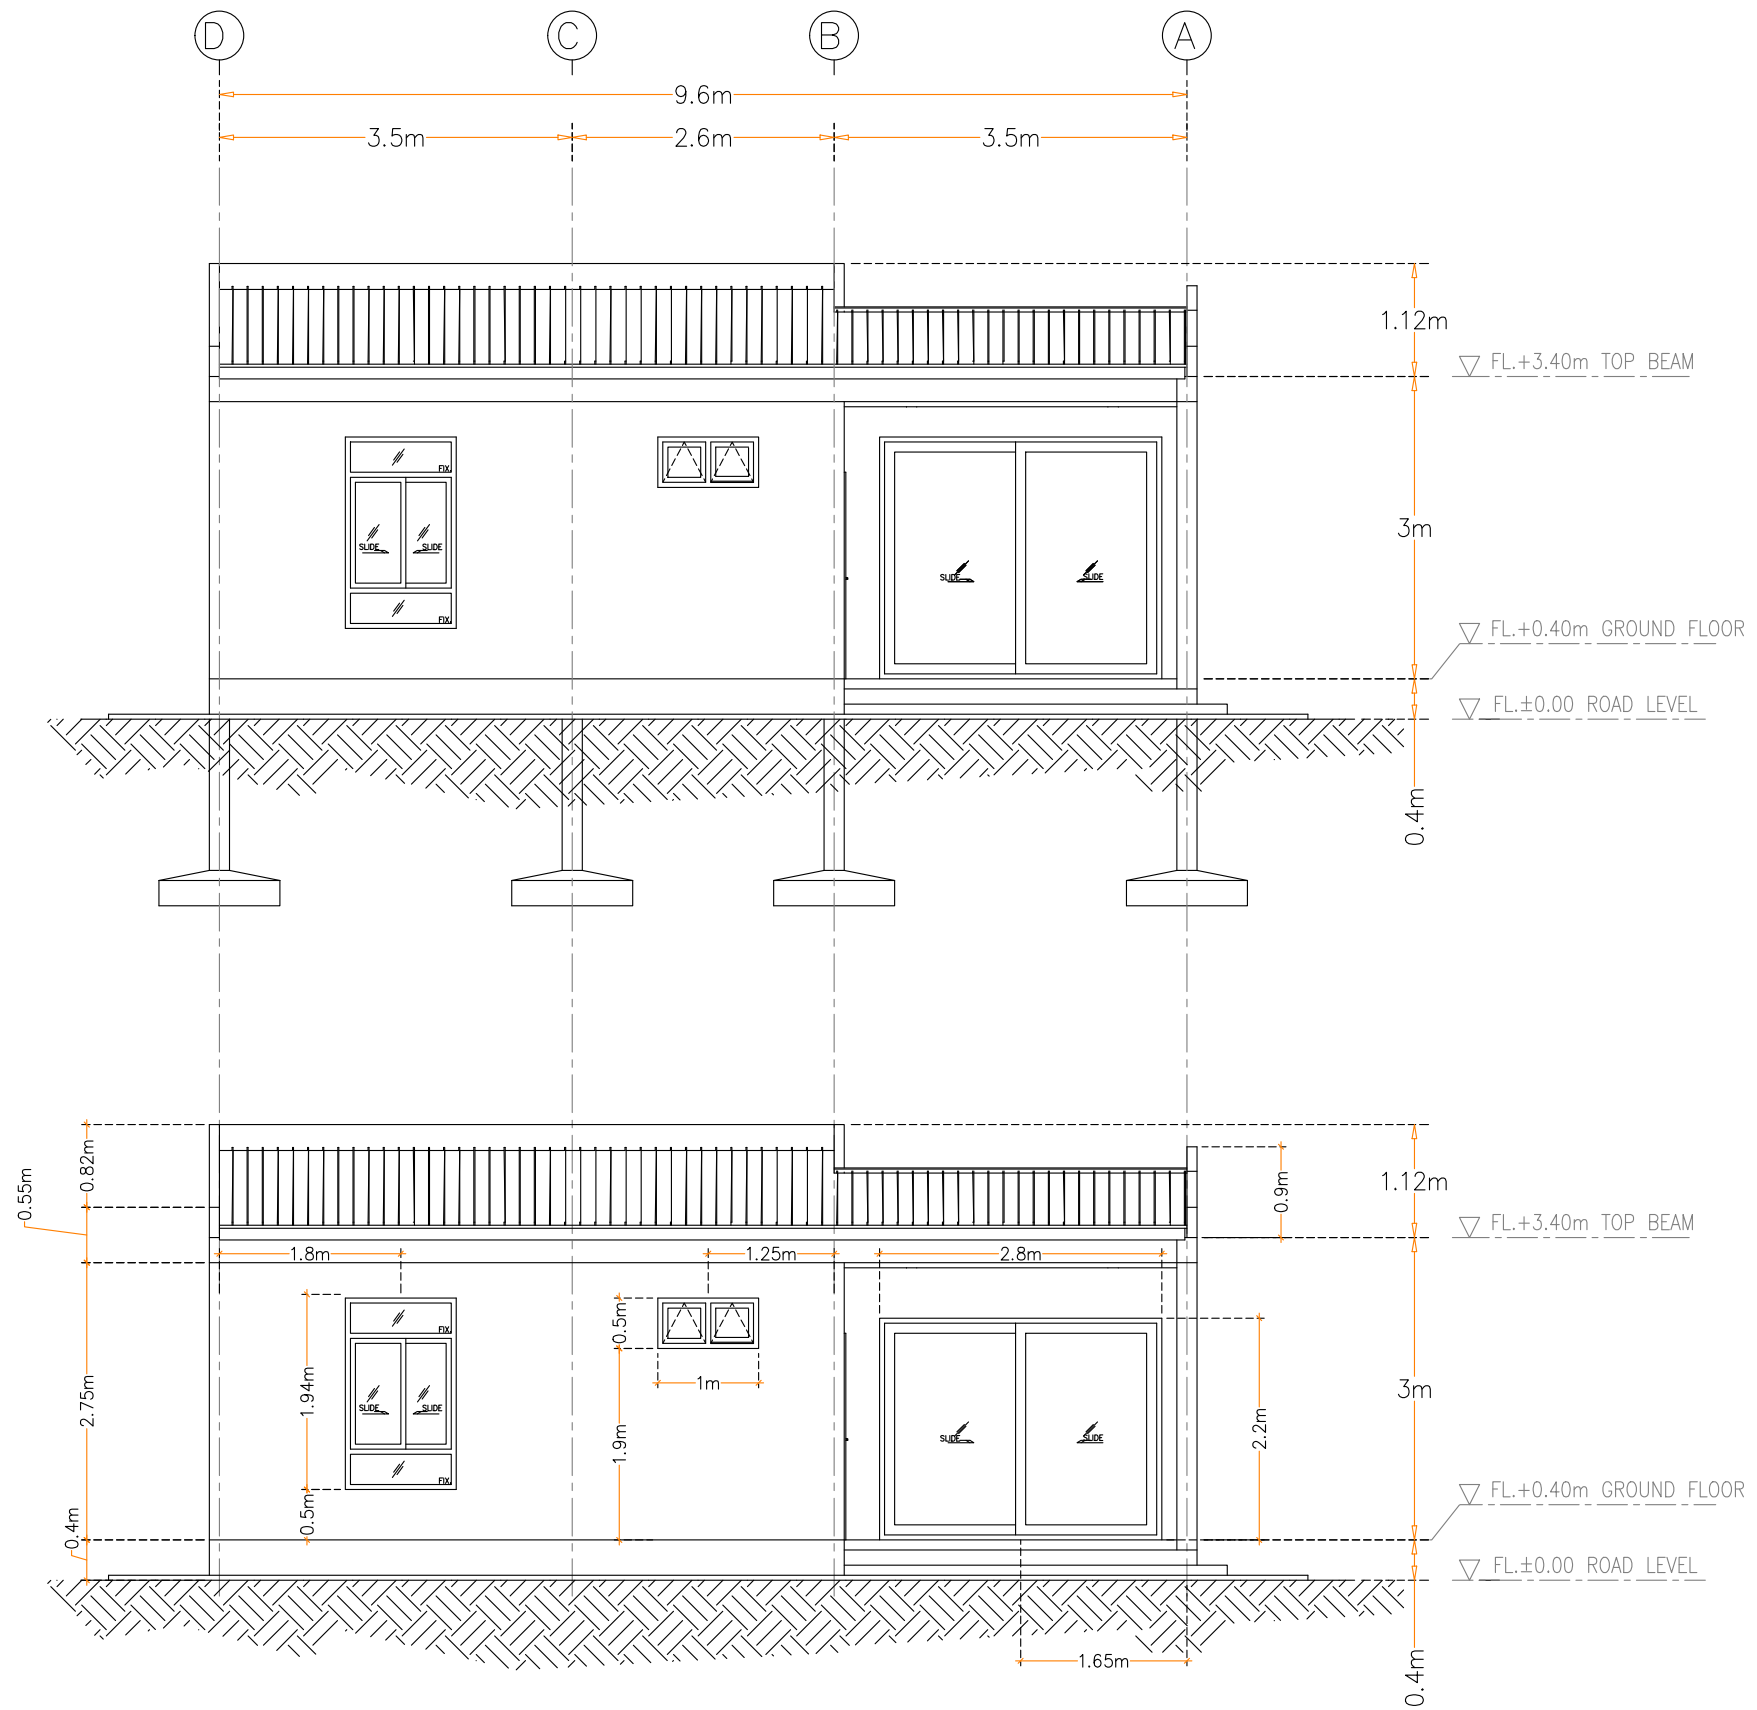

BACK VIEW
SCALE 1: 75 [A3]

SCALE:
DRAWING No.
A - 05

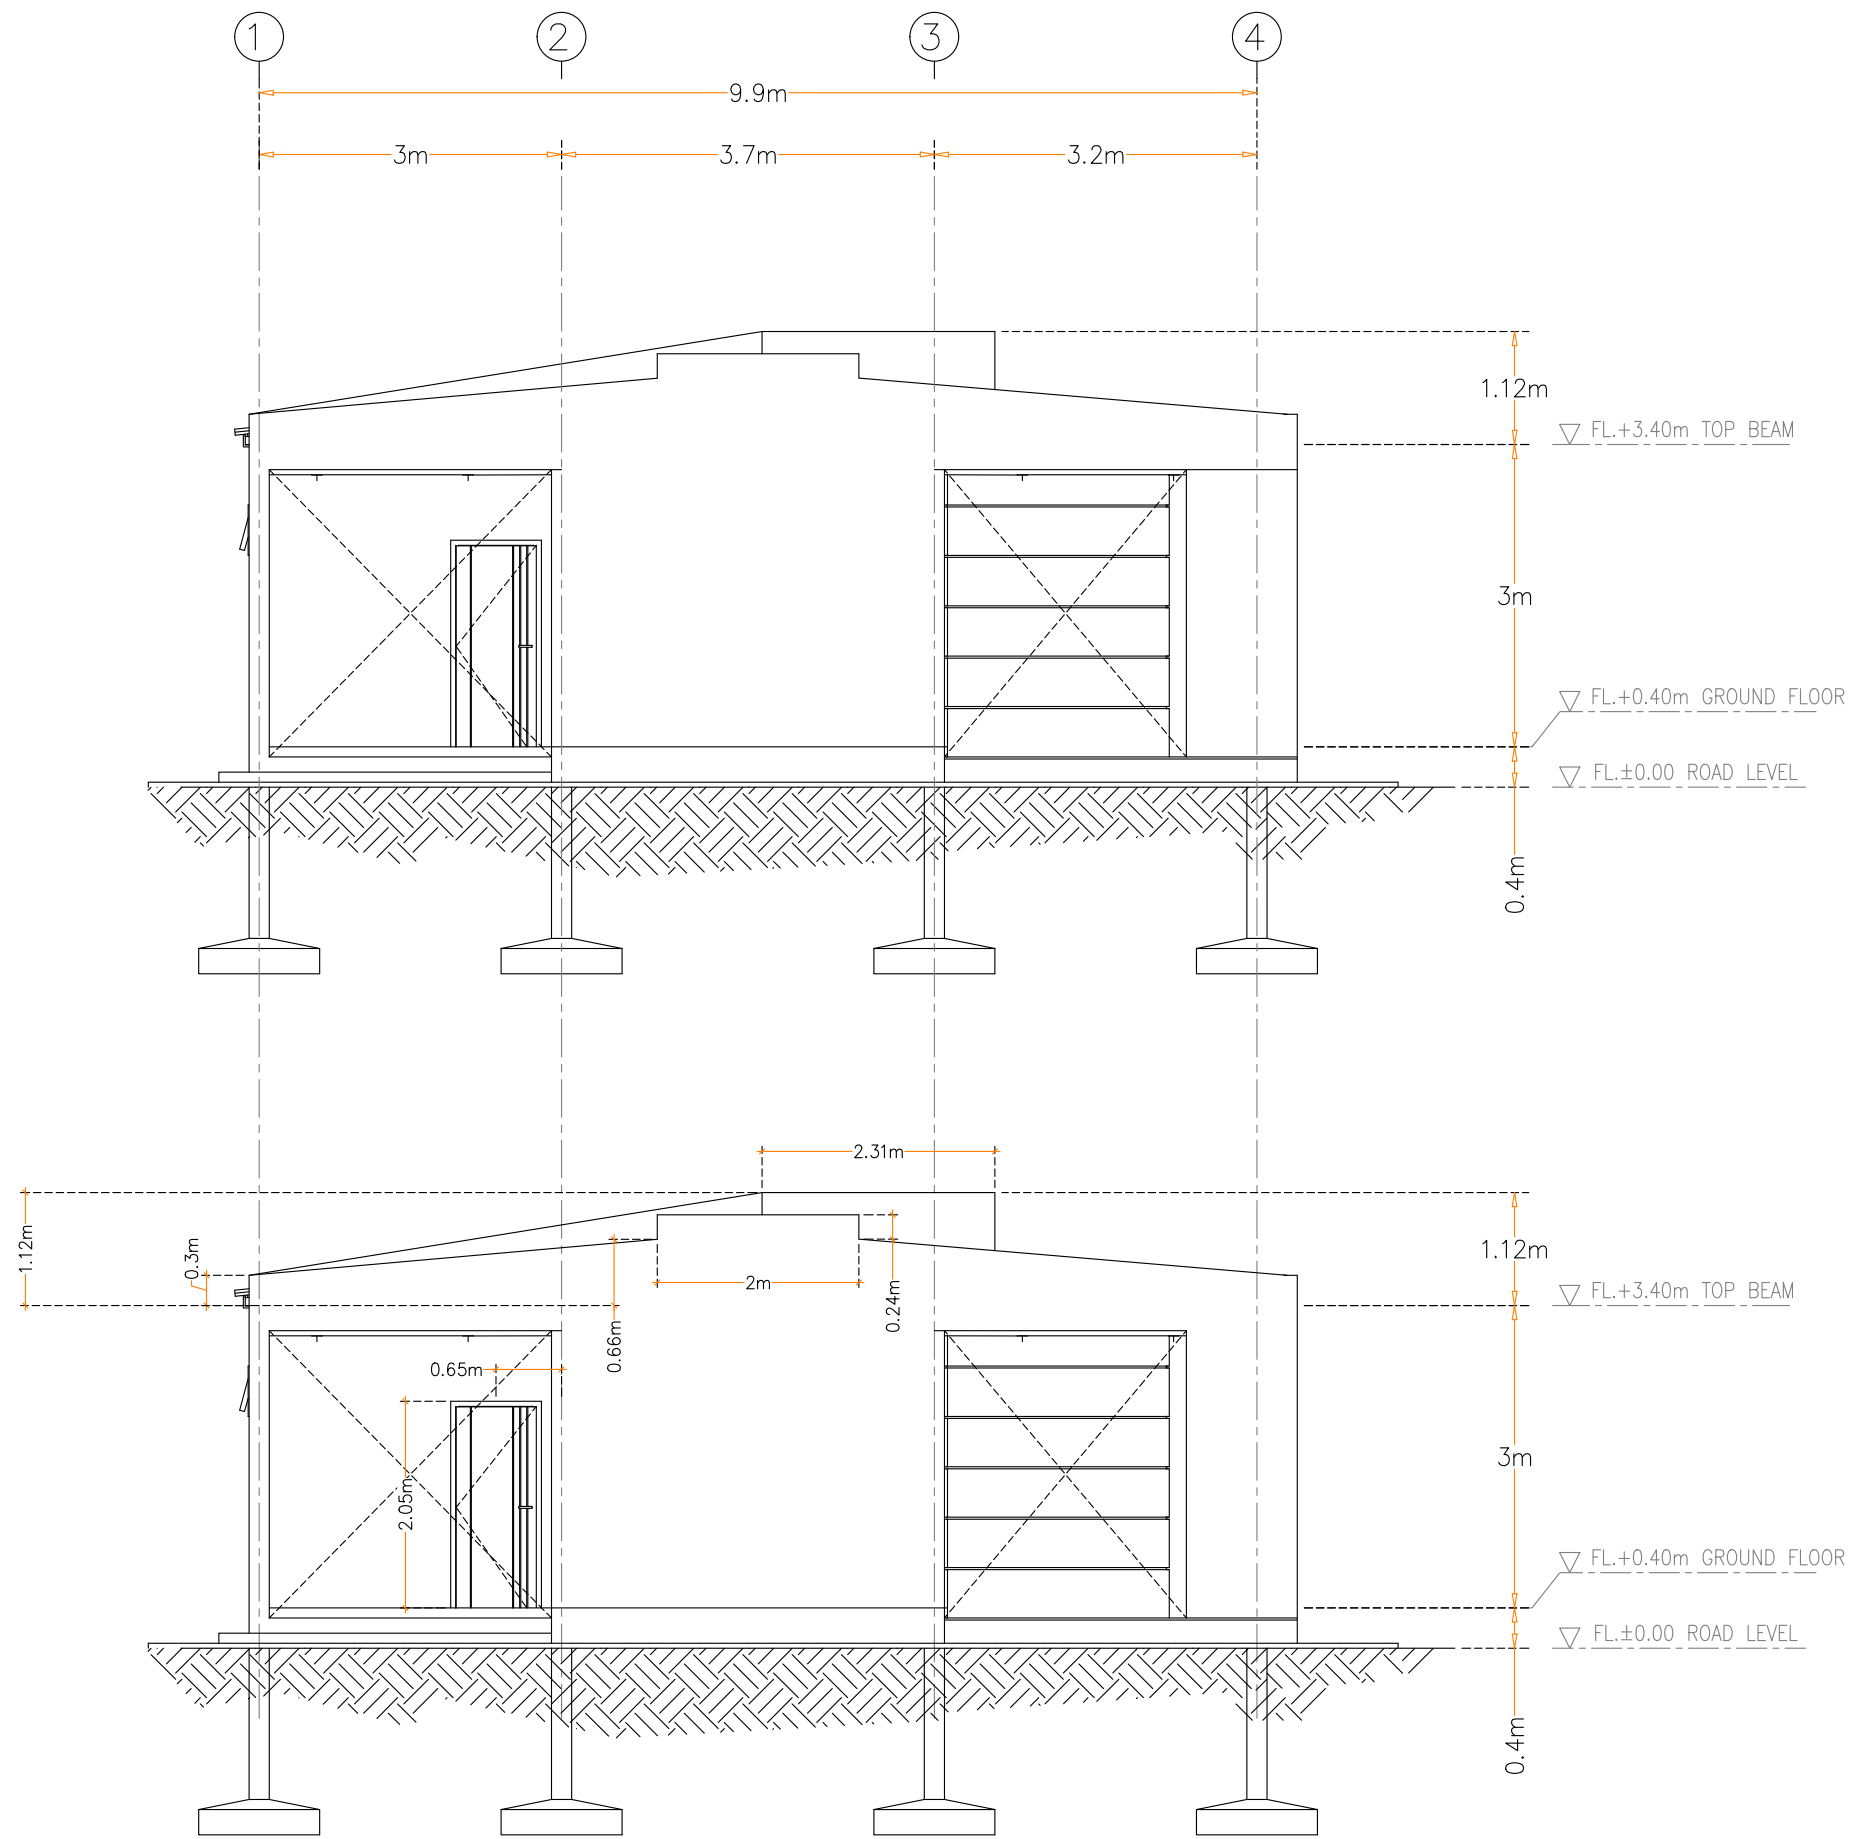

LEFT VIEW

SCALE


1: 75 [A3]

SCALE:


DRAWING No.

A - 06

SECTION OA
SCALE 1: 75 [A3]

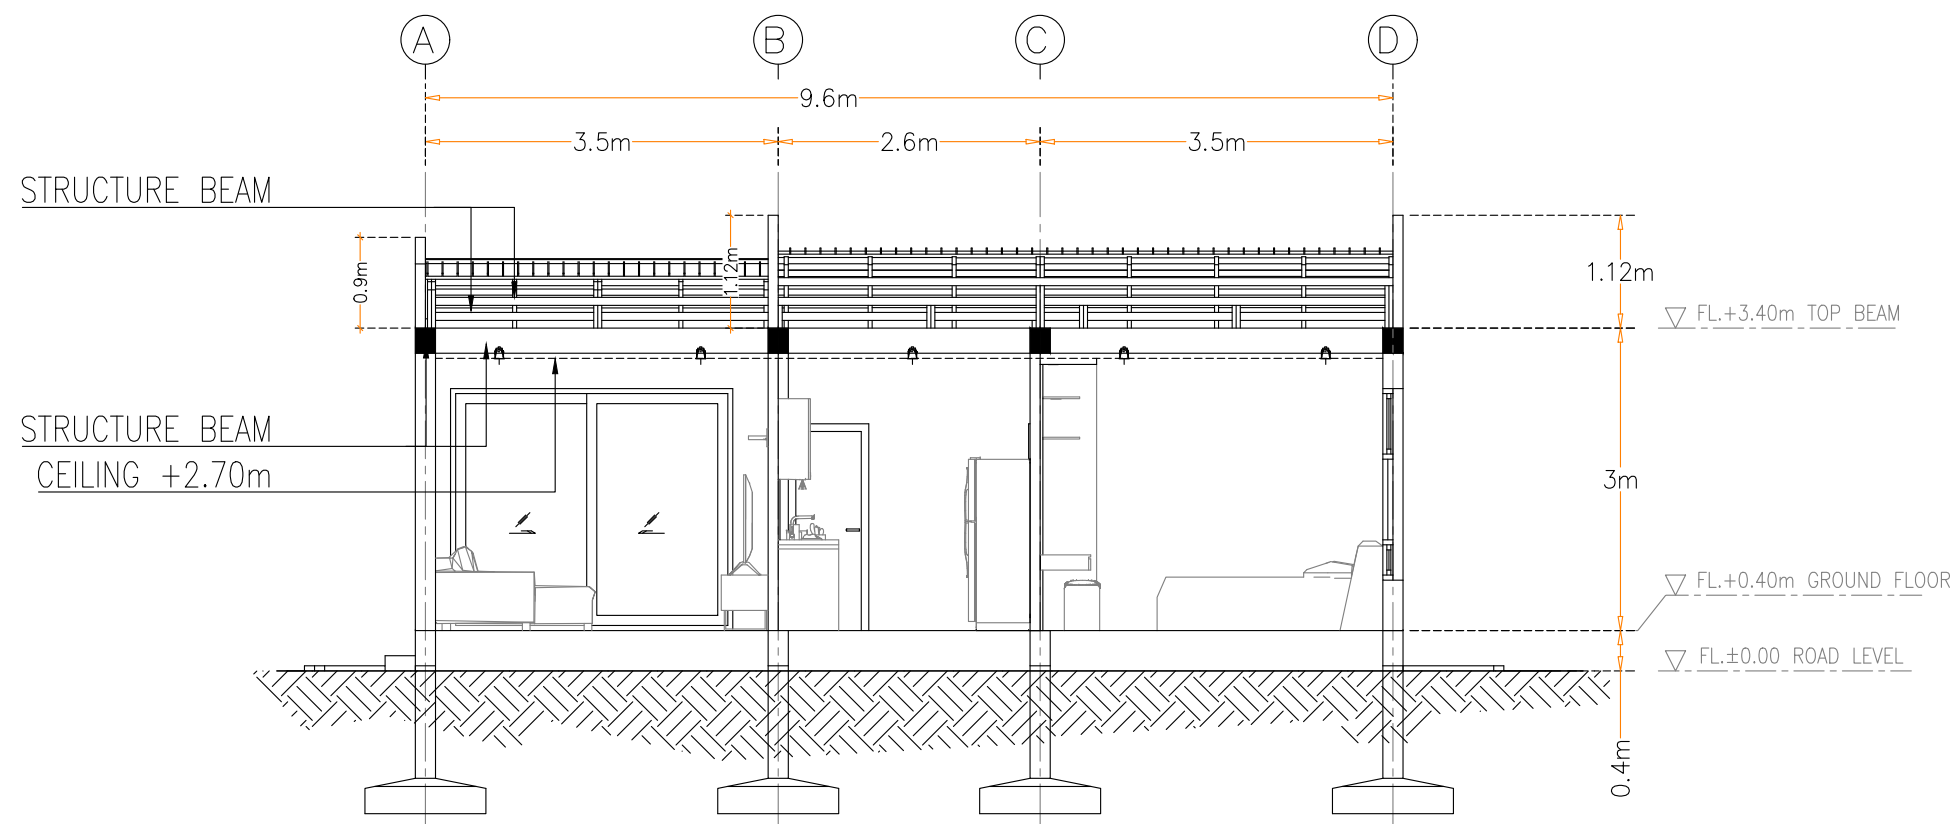


SECTION OB
SCALE 1: 75 [A3]


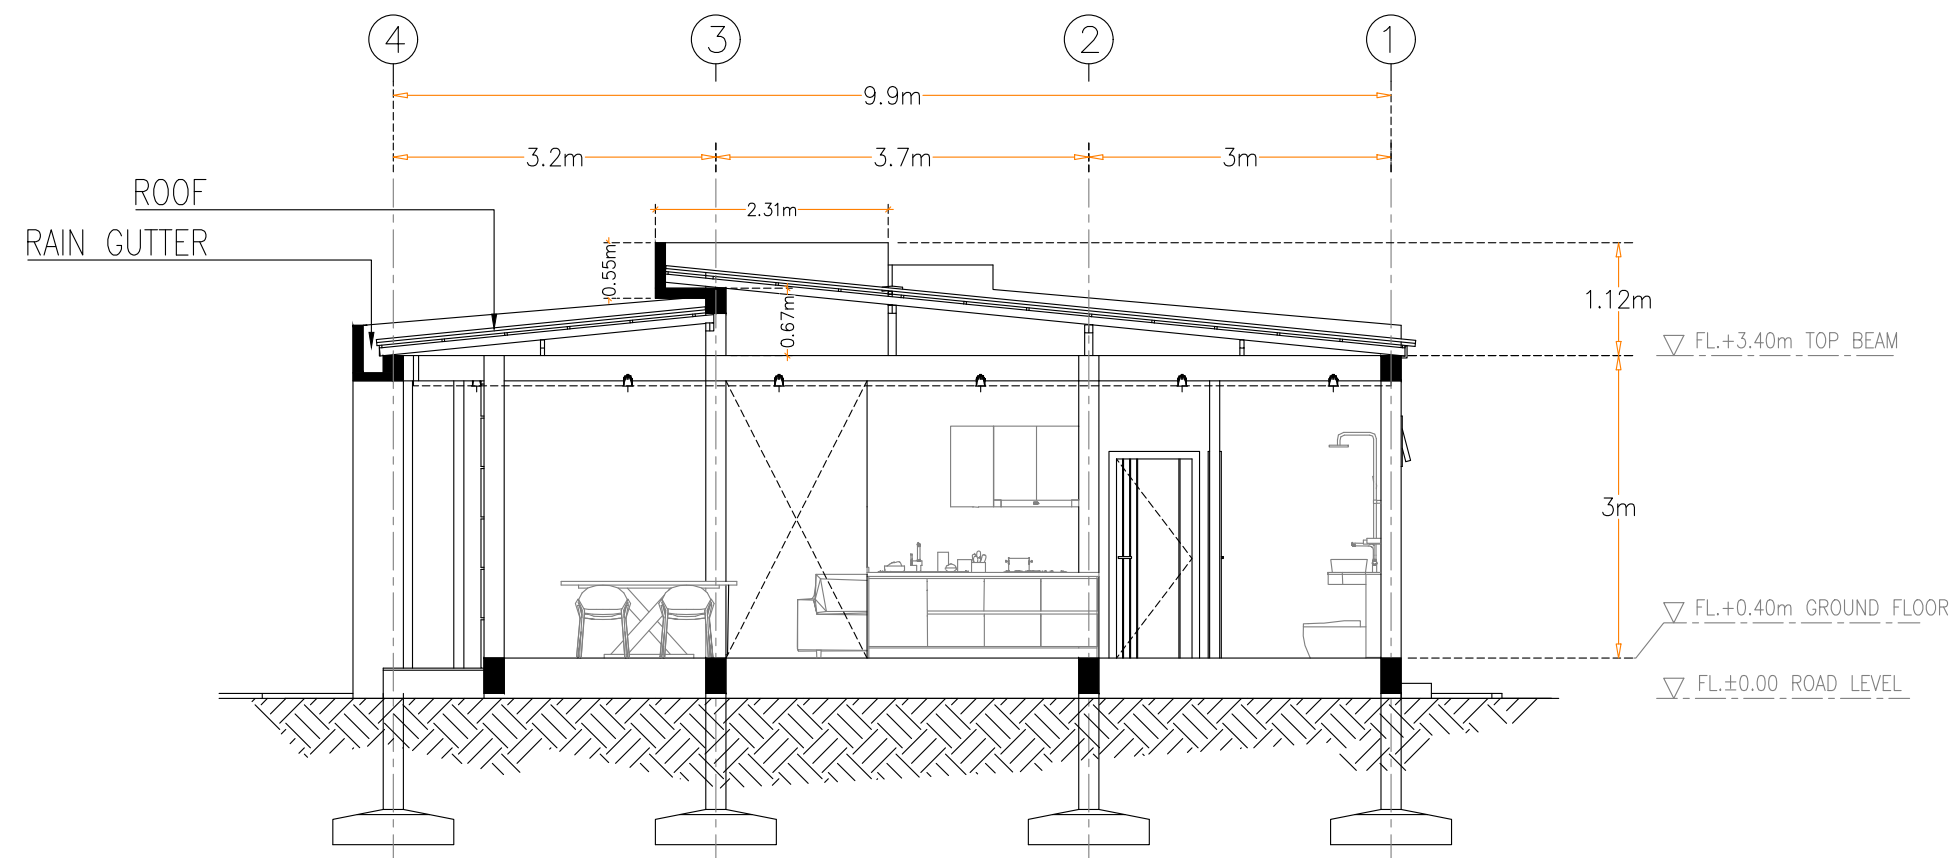


SECTION VIEW
SCALE 1: 75 [A3]






SCALE:
DRAWING No.
A - 07

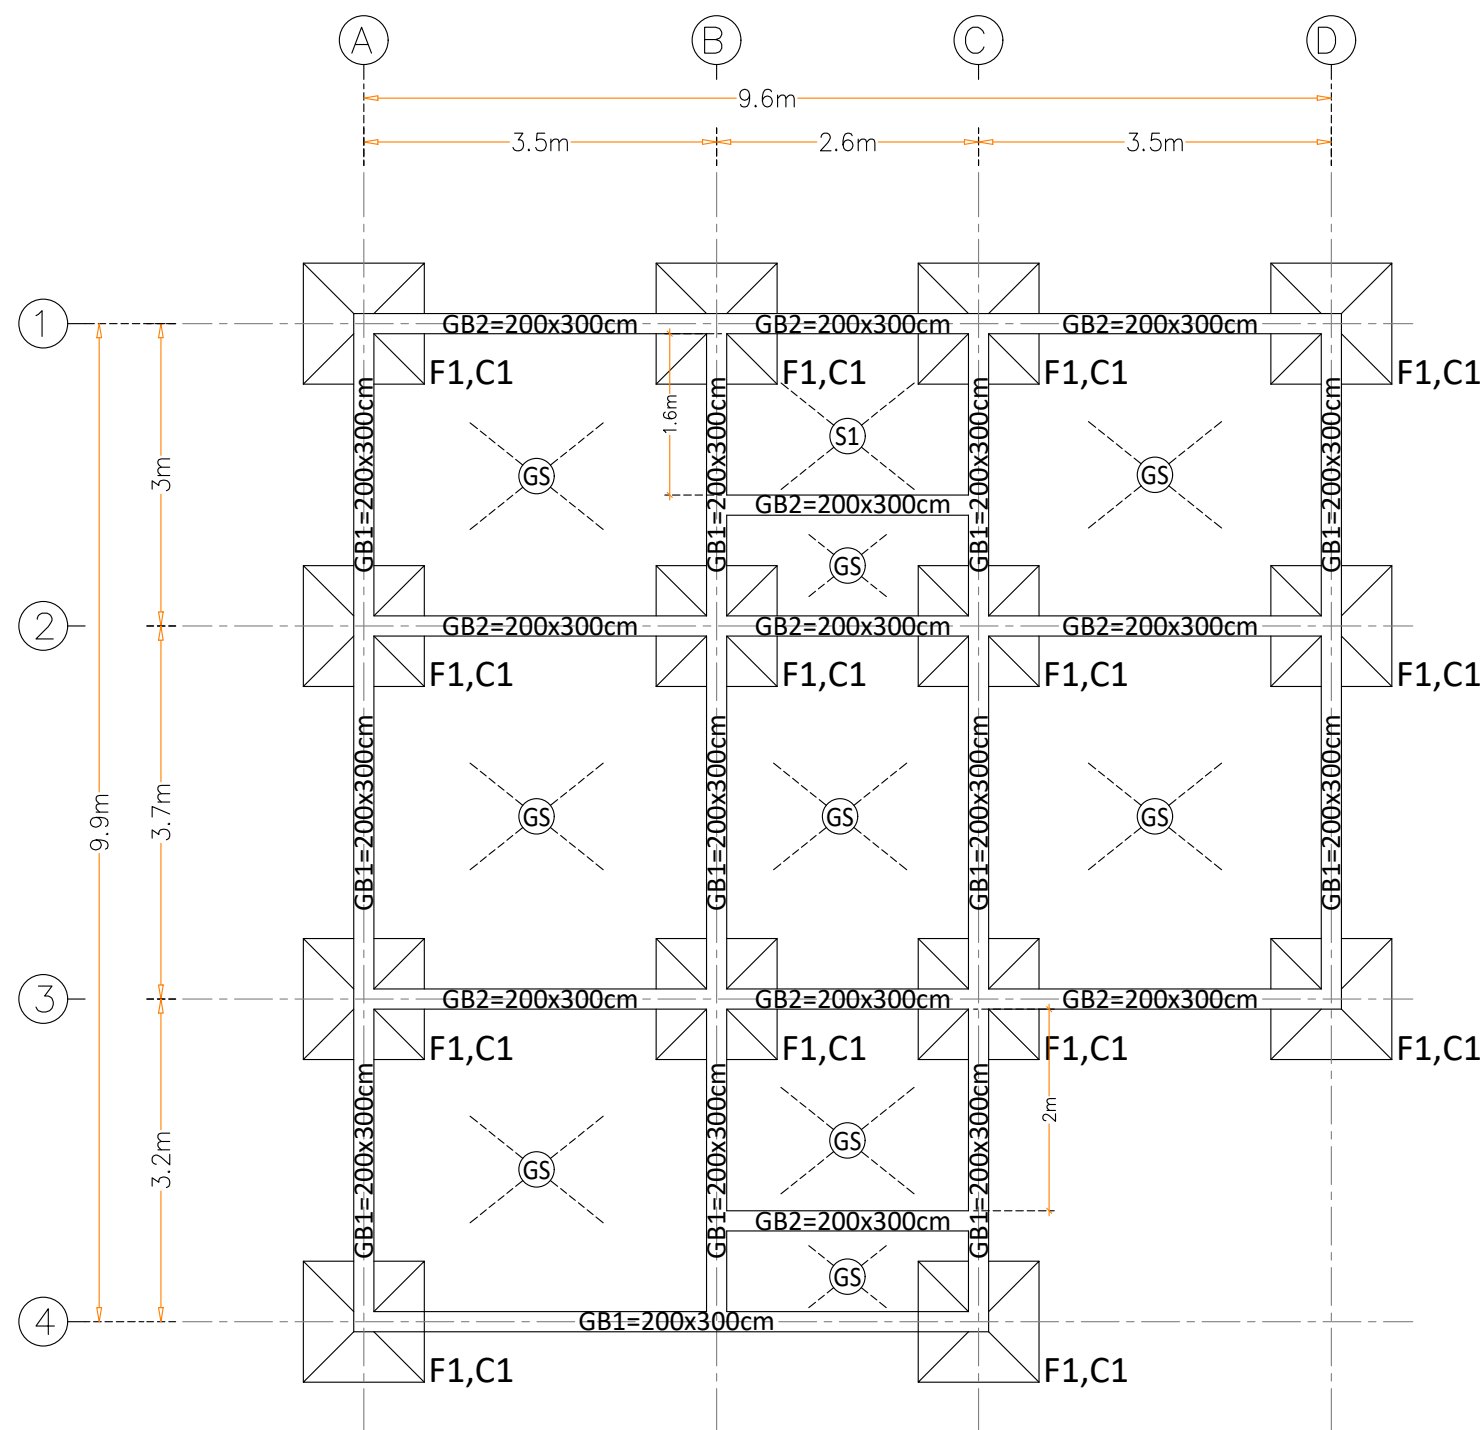


FOOTING, BEAM & SLAB
SCALE 1: 75 [A3]

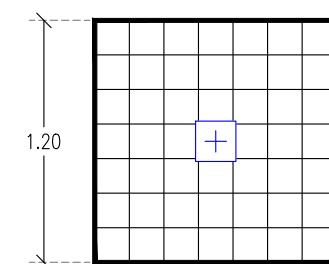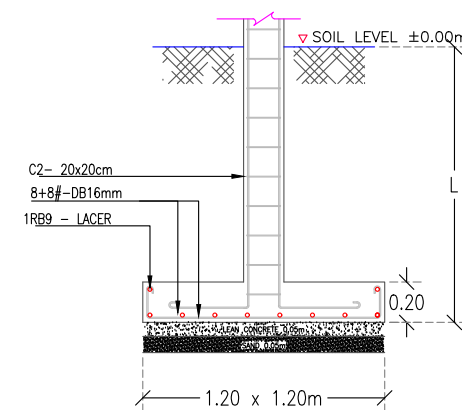

FOOTING - F1

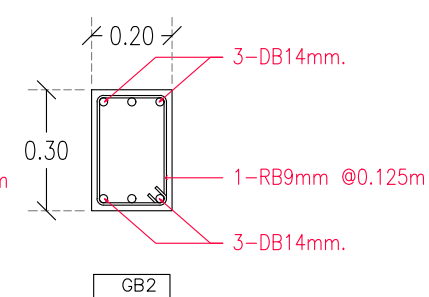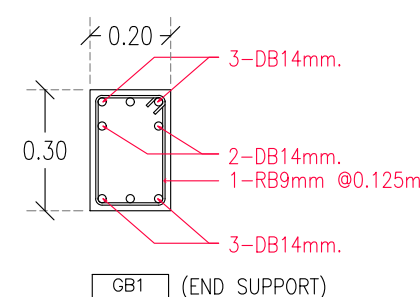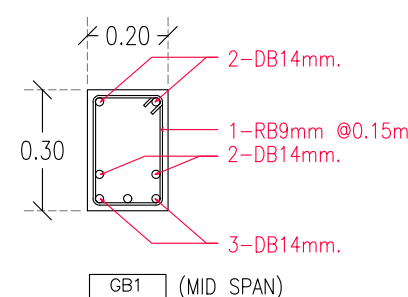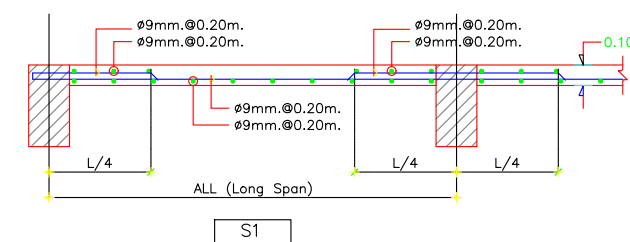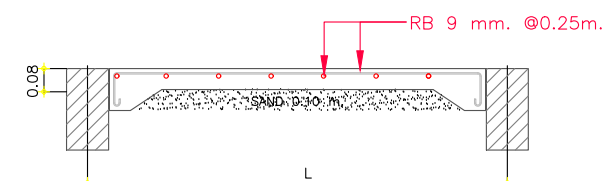


1F BEAM DETAIL

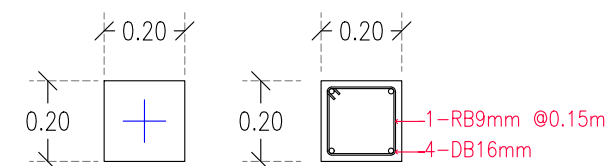


1F COLUMN DETAIL


SCALE:
DRAWING No.
S - 01

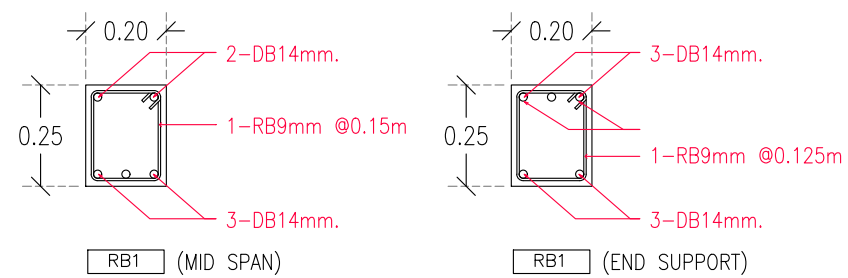

ROOF STRUCTURE

SCALE 1:75 [A3]

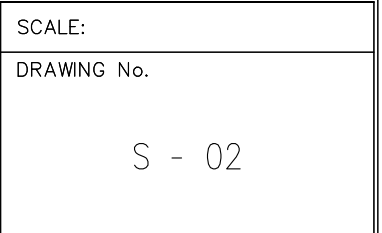


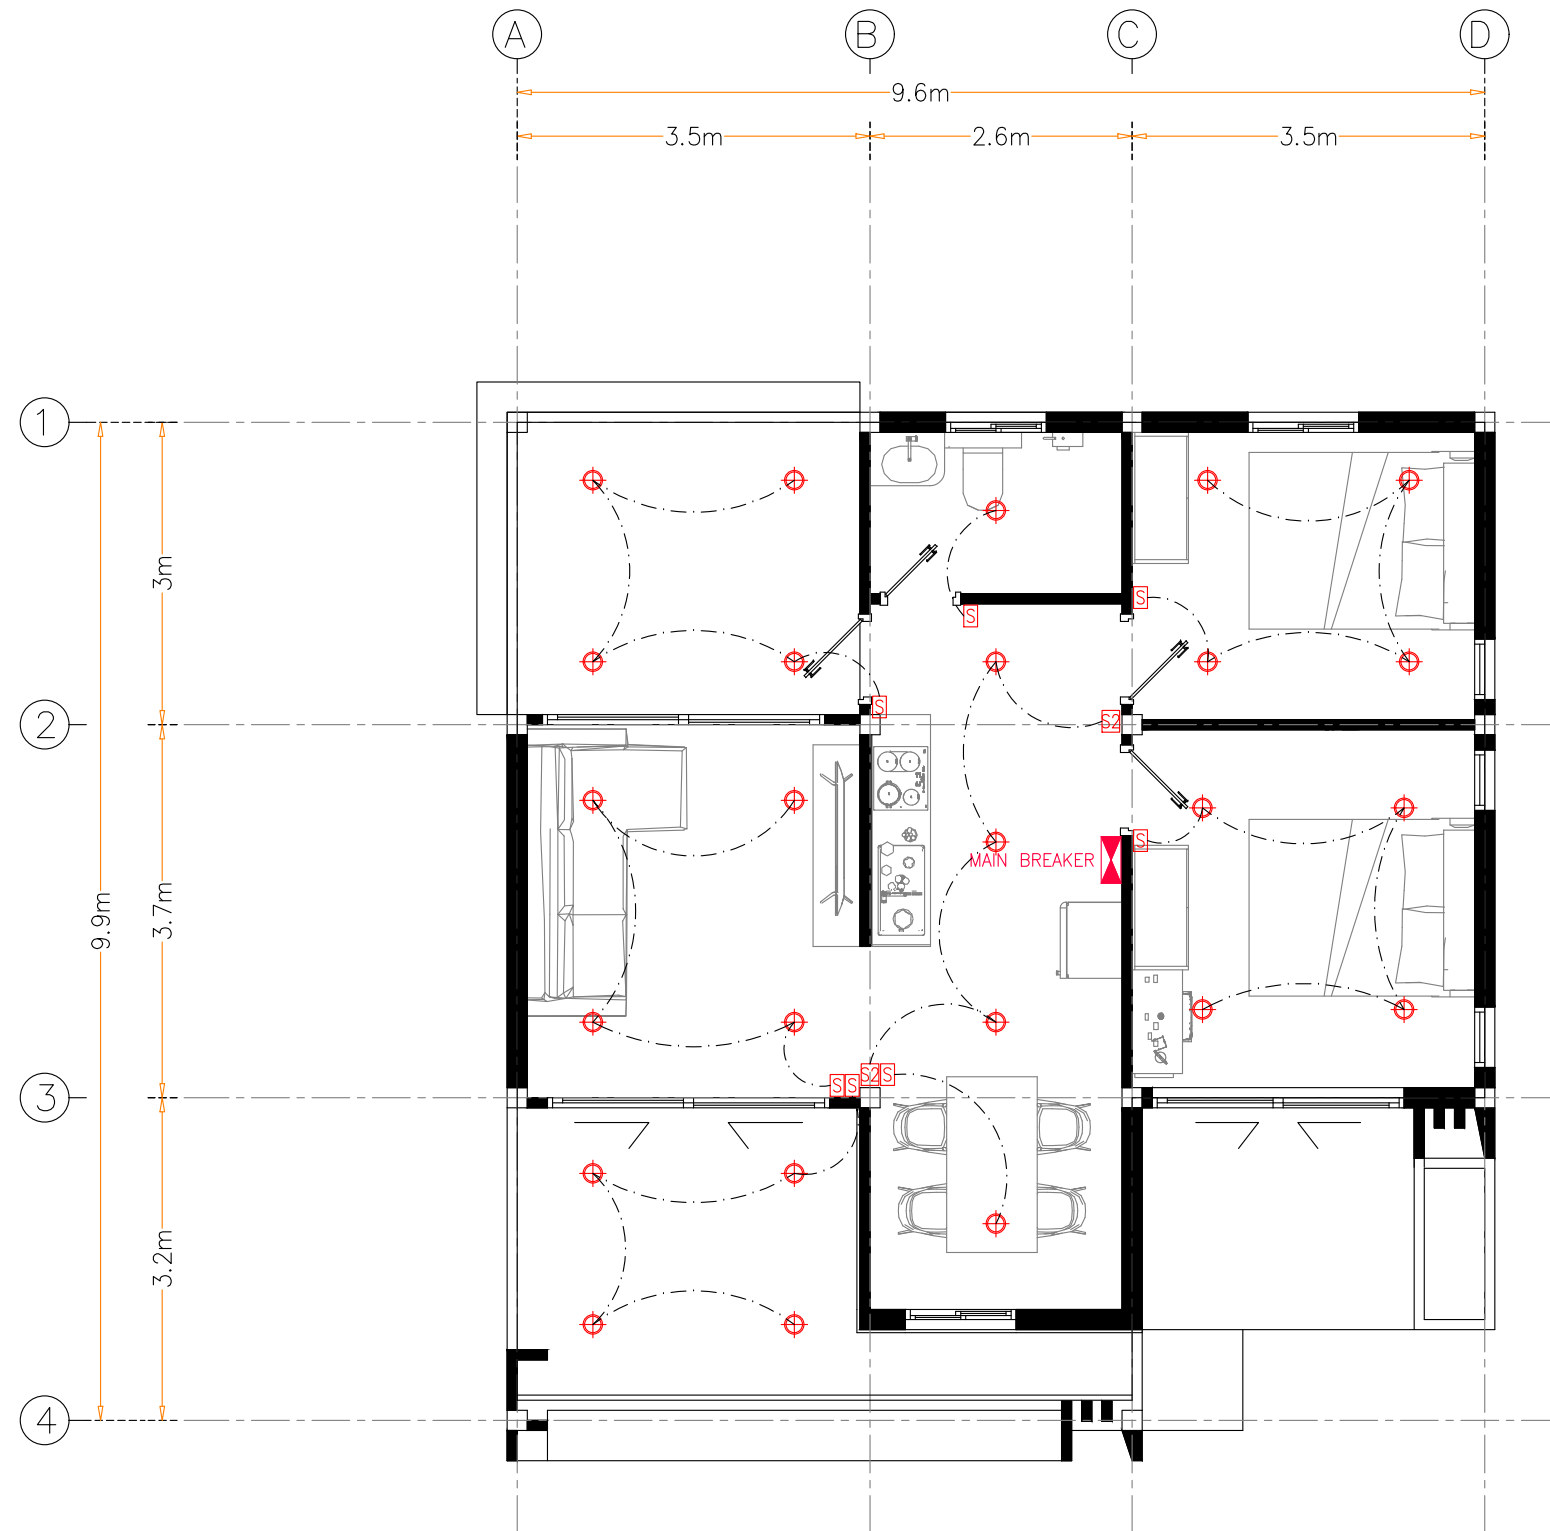

- ⊕ = DOWNLIGHT 20W
- Ⓢ = LIGHTING SWITCH
- Ⓢ2 = 2 WAY SWITCH

LIGHTING PLAN
SCALE 1: 75 [A3]

SCALE:
DRAWING No.
E - 01

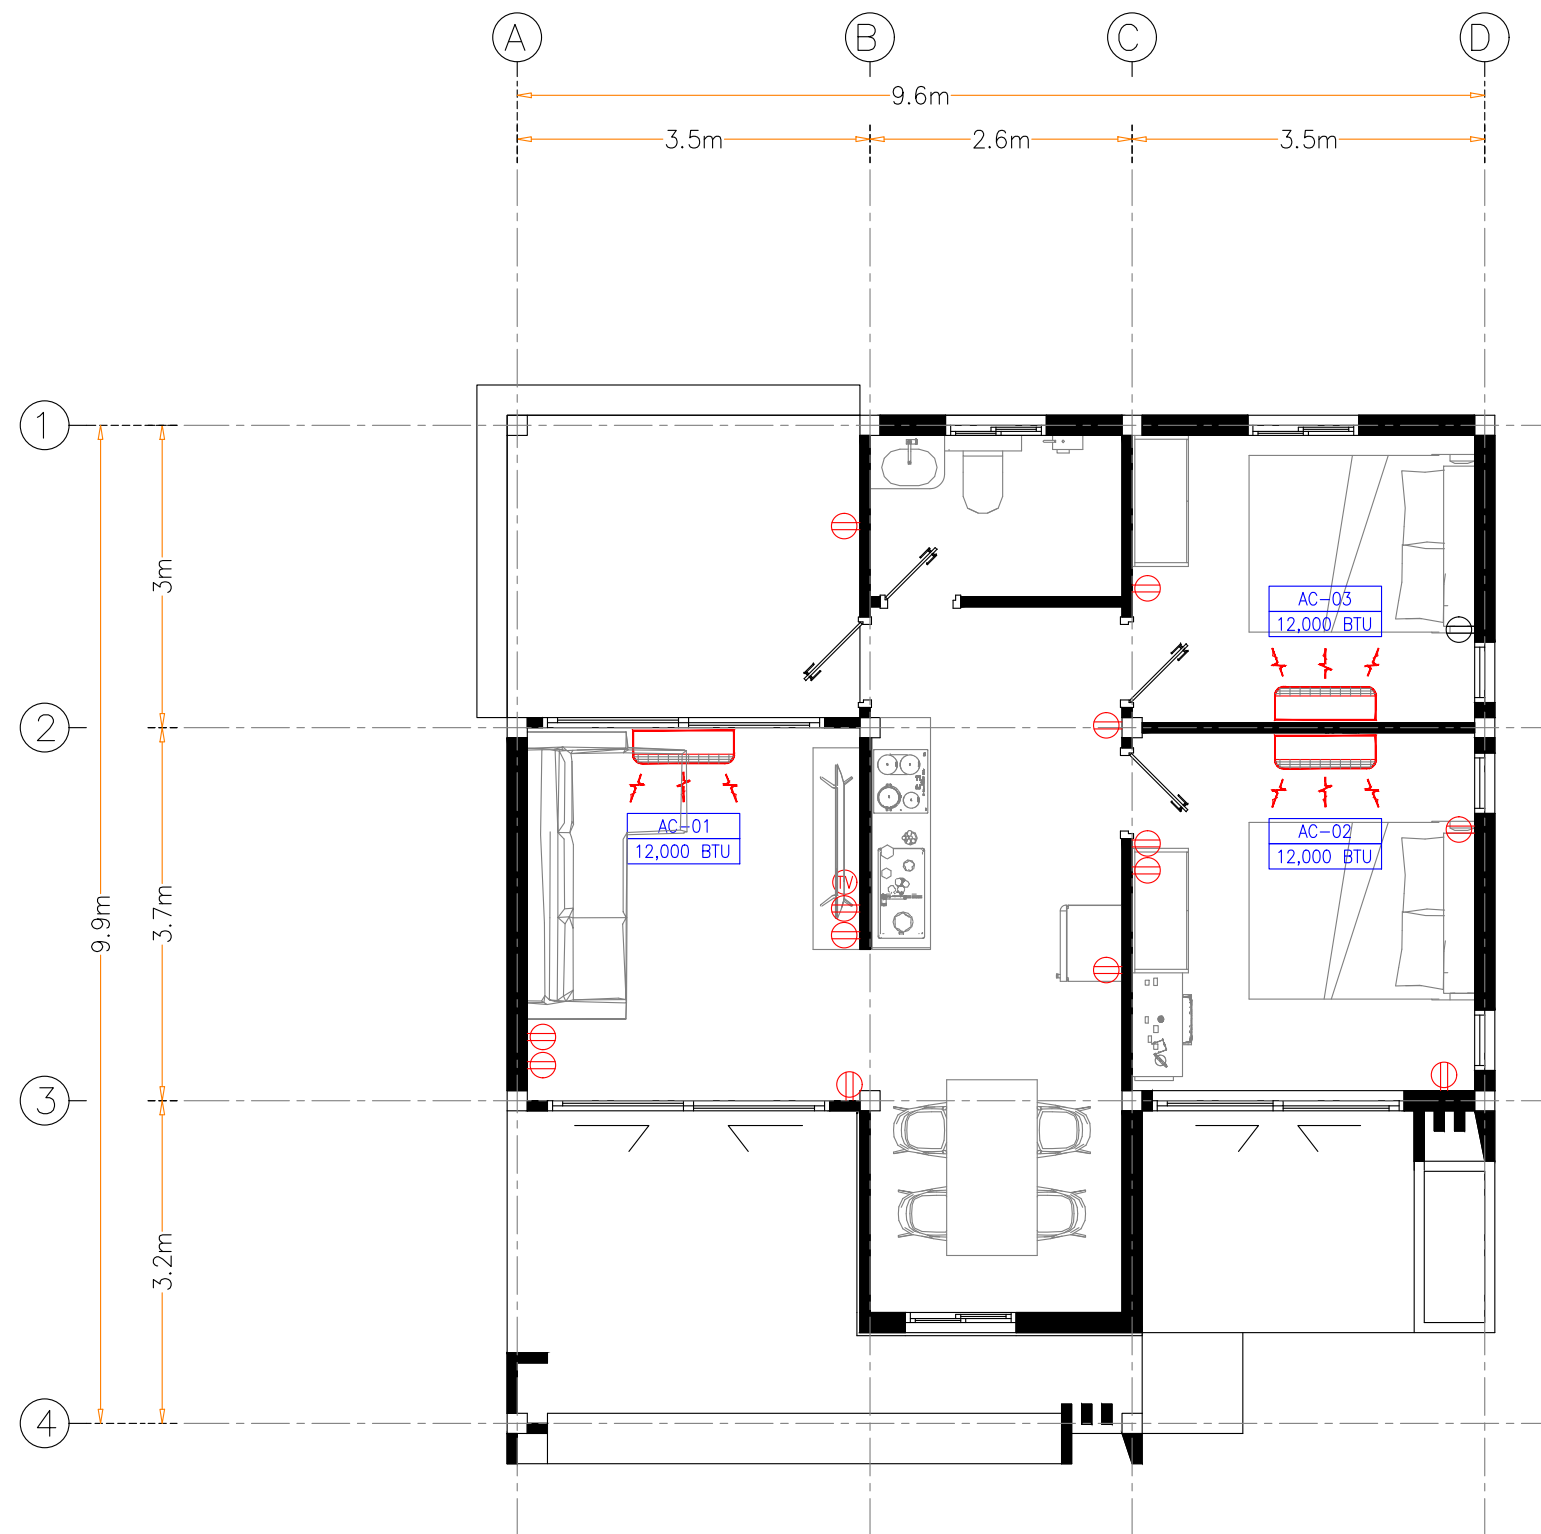

	=	AIR CONDITIONER
	=	RECEPTACLE
	=	TELEVISION

RECEPTACLE & AIR PLAN
SCALE 1: 75 [A3]

SCALE:
DRAWING No.
E - 02